



1 GROUND FLOOR LIGHTING LAYOUT
SCALE: 1:100

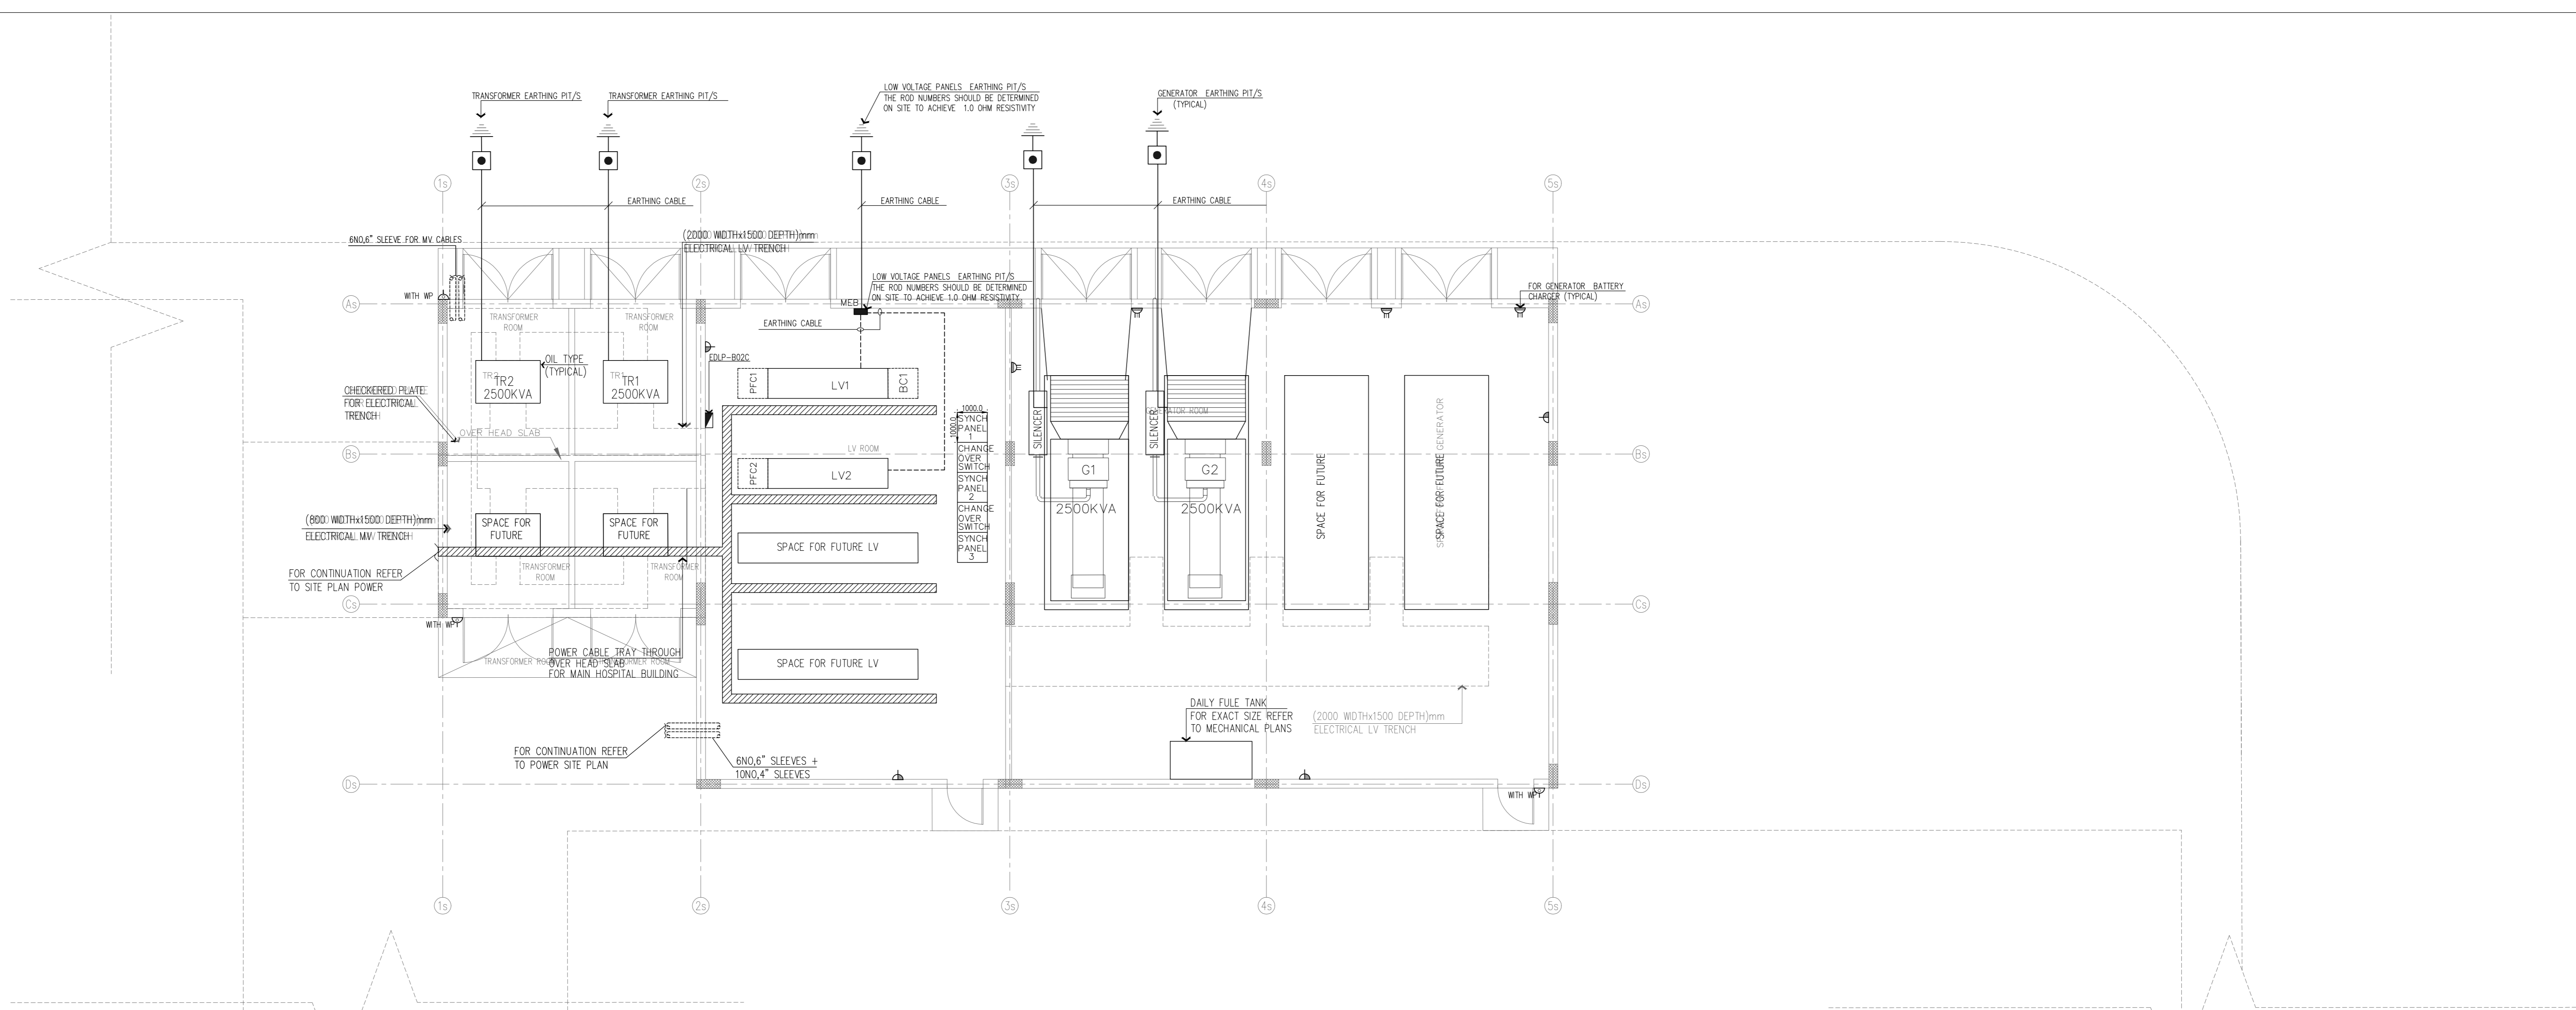

2 GROUND FLOOR POWER LAYOUT
SCALE: 1:100

General Notes :

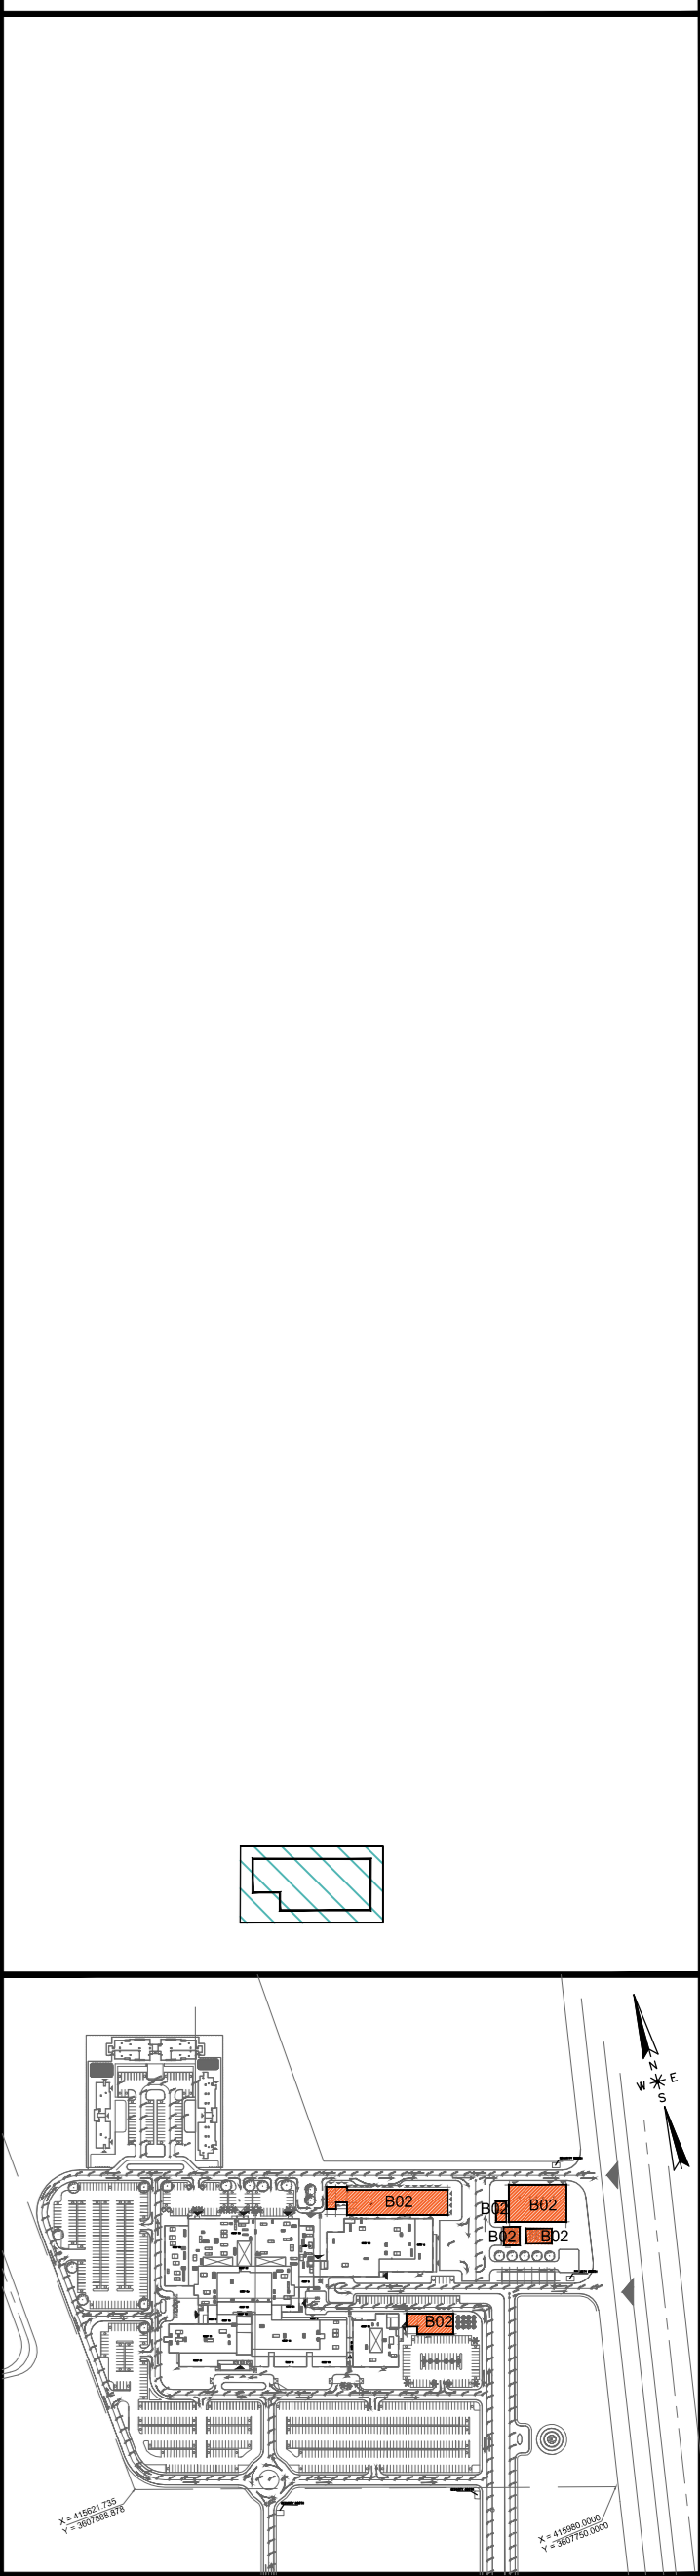

MINISTRY OF HIGHER EDUCATION AND SCIENTIFIC RESEARCH
University of Karba



PROJECT MANAGEMENT CONSULTANT:
AM TECH

MAIN CONTRACTOR:
FOURTH DIMENSION
Consulting Engineering & Construction
CIB.C

PRINCIPAL ENGINEERING CONSULTANT:
ARABTECH JARDANEH

CONSULTING HEALTH PLANNERS:
HDP healthcare designers and project managers

CONSULTING INTERNATIONAL ARCHITECTS:
LEO A DALY PLANNING ARCHITECTURE ENGINEERING INTERIORS

THIS DRAWING IS THE COPYRIGHT OF ARABTECH JARDANEH ENGINEERS & ARCHITECTS AND MUST NOT BE RETAINED, COPIED OR USED WITHOUT THE CONSULTANTS AUTHORIZATION


REV.	DESCRIPTION	APPD. BY	DATE

DRAWN BY: E.D. DESIGNED BY: A.D.
CHECKED BY: M.M.H. APPROVED BY: F.J.
QC REVIEW BY: DWG ISSUE DATE: 26.10.2014


PROJECT:
KARBALA 600 BED TEACHING UNIVERSITY HOSPITAL, IRAQ

DRAWING TITLE:
BLOCK-02c ANCILLARY BUILDING GROUND FLOOR PLAN LIGHTING LAYOUT & POWER LAYOUT

JOB # 01586 DWG: KH-EW-101 BLOCK # B2c
1:100 @ (A0) Sh. 01 of 01 REV # RO

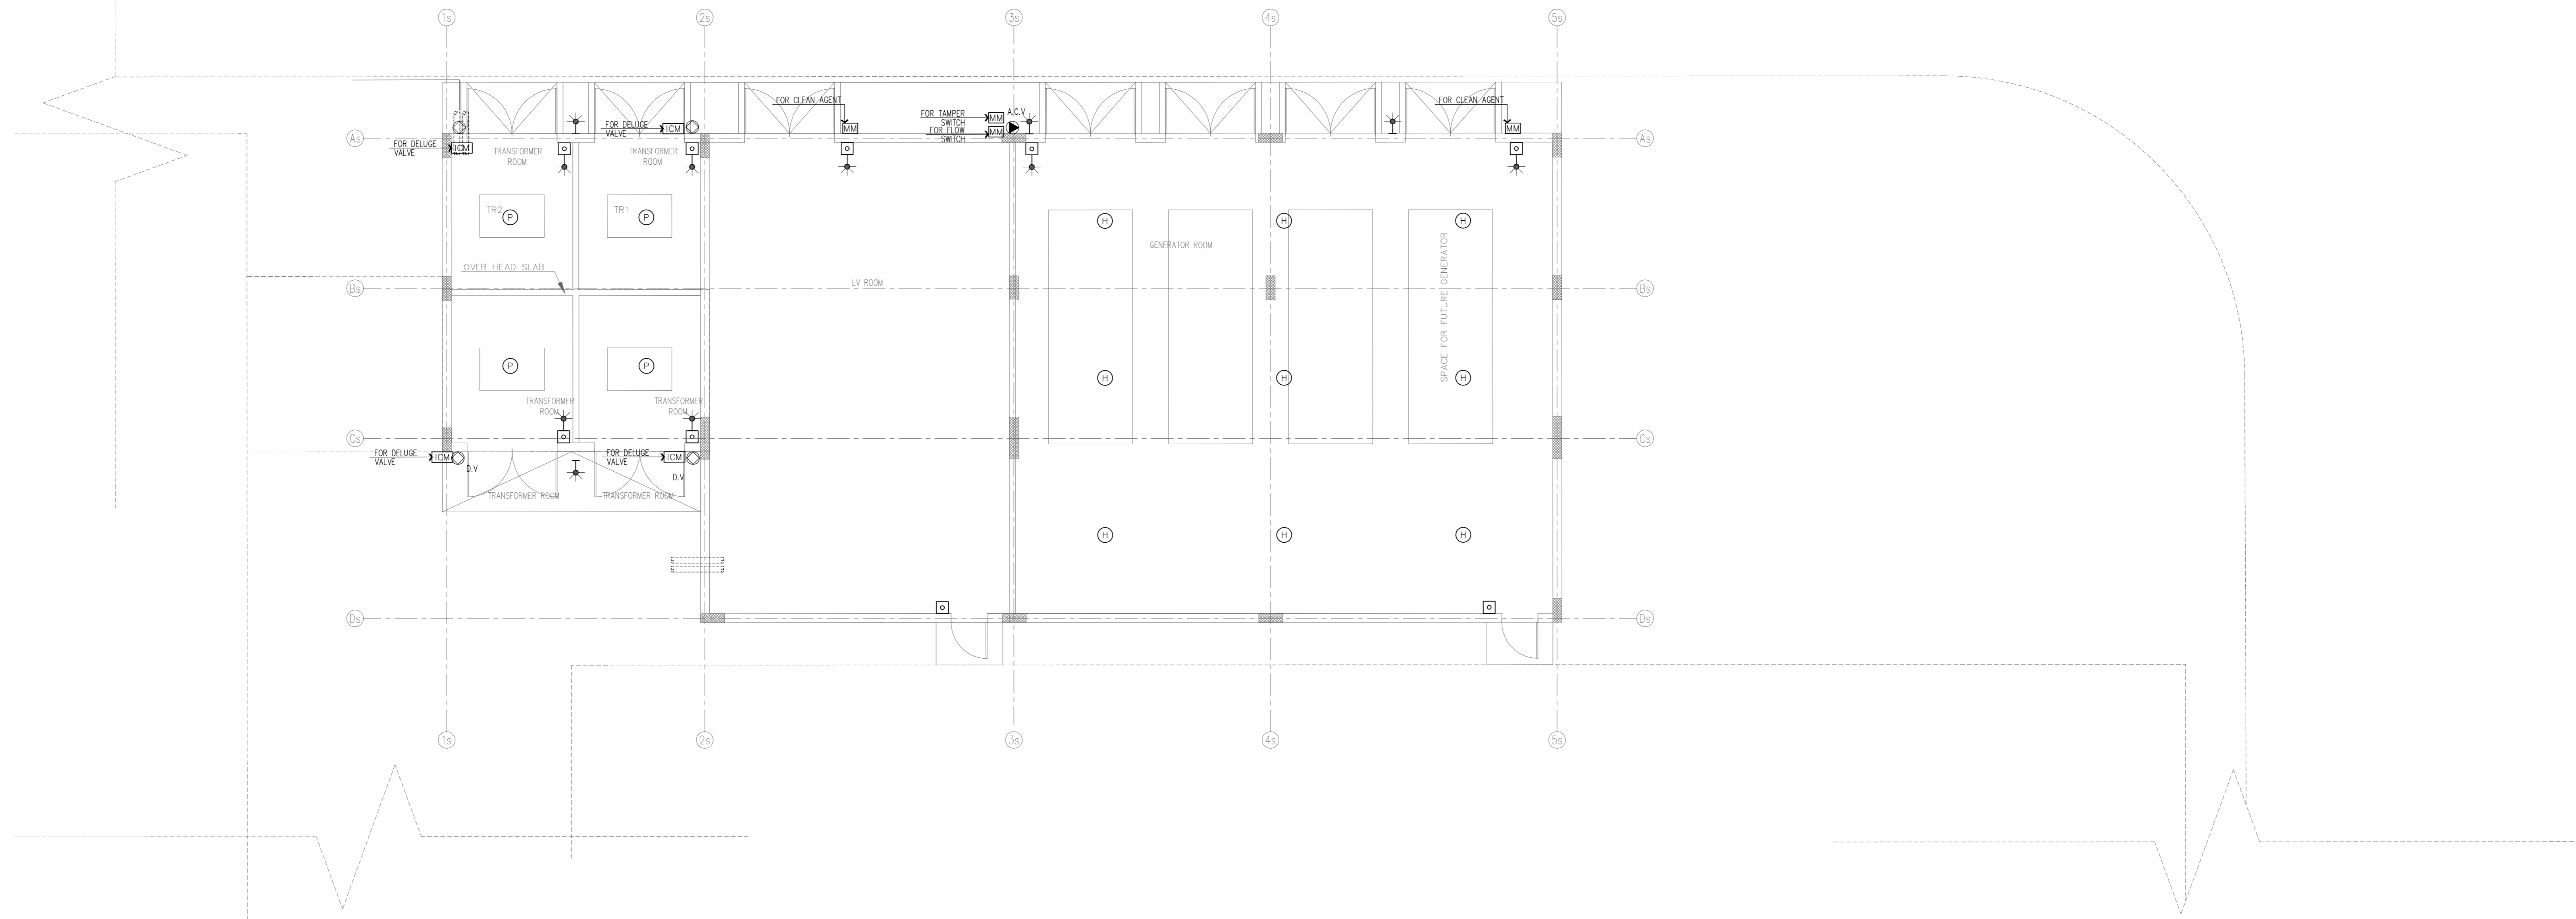


1 GROUND FLOOR FIRE ALARM SYSTEM
SCALE: 1:100

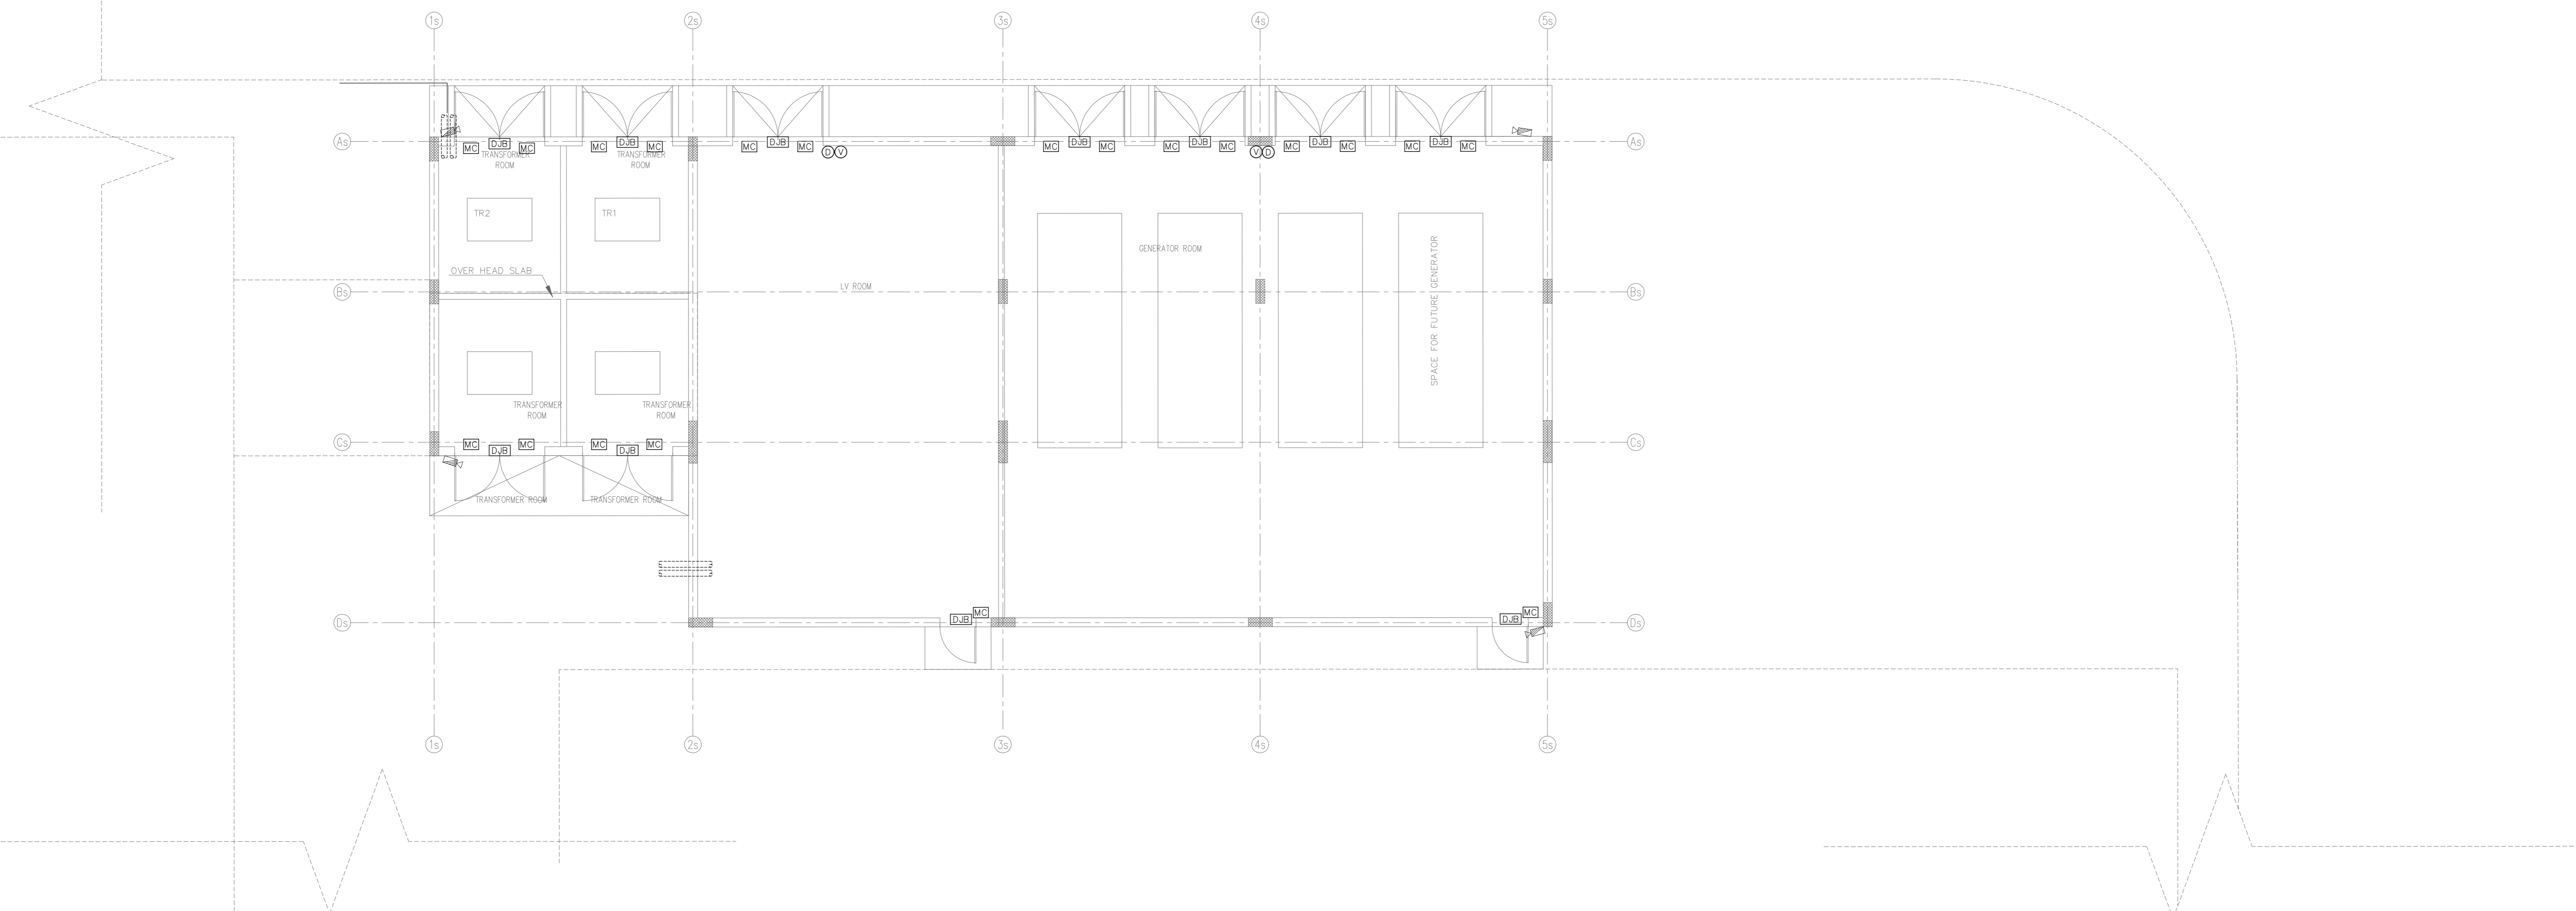

2 GROUND FLOOR IT SYSTEM
SCALE: 1:100

General Notes :

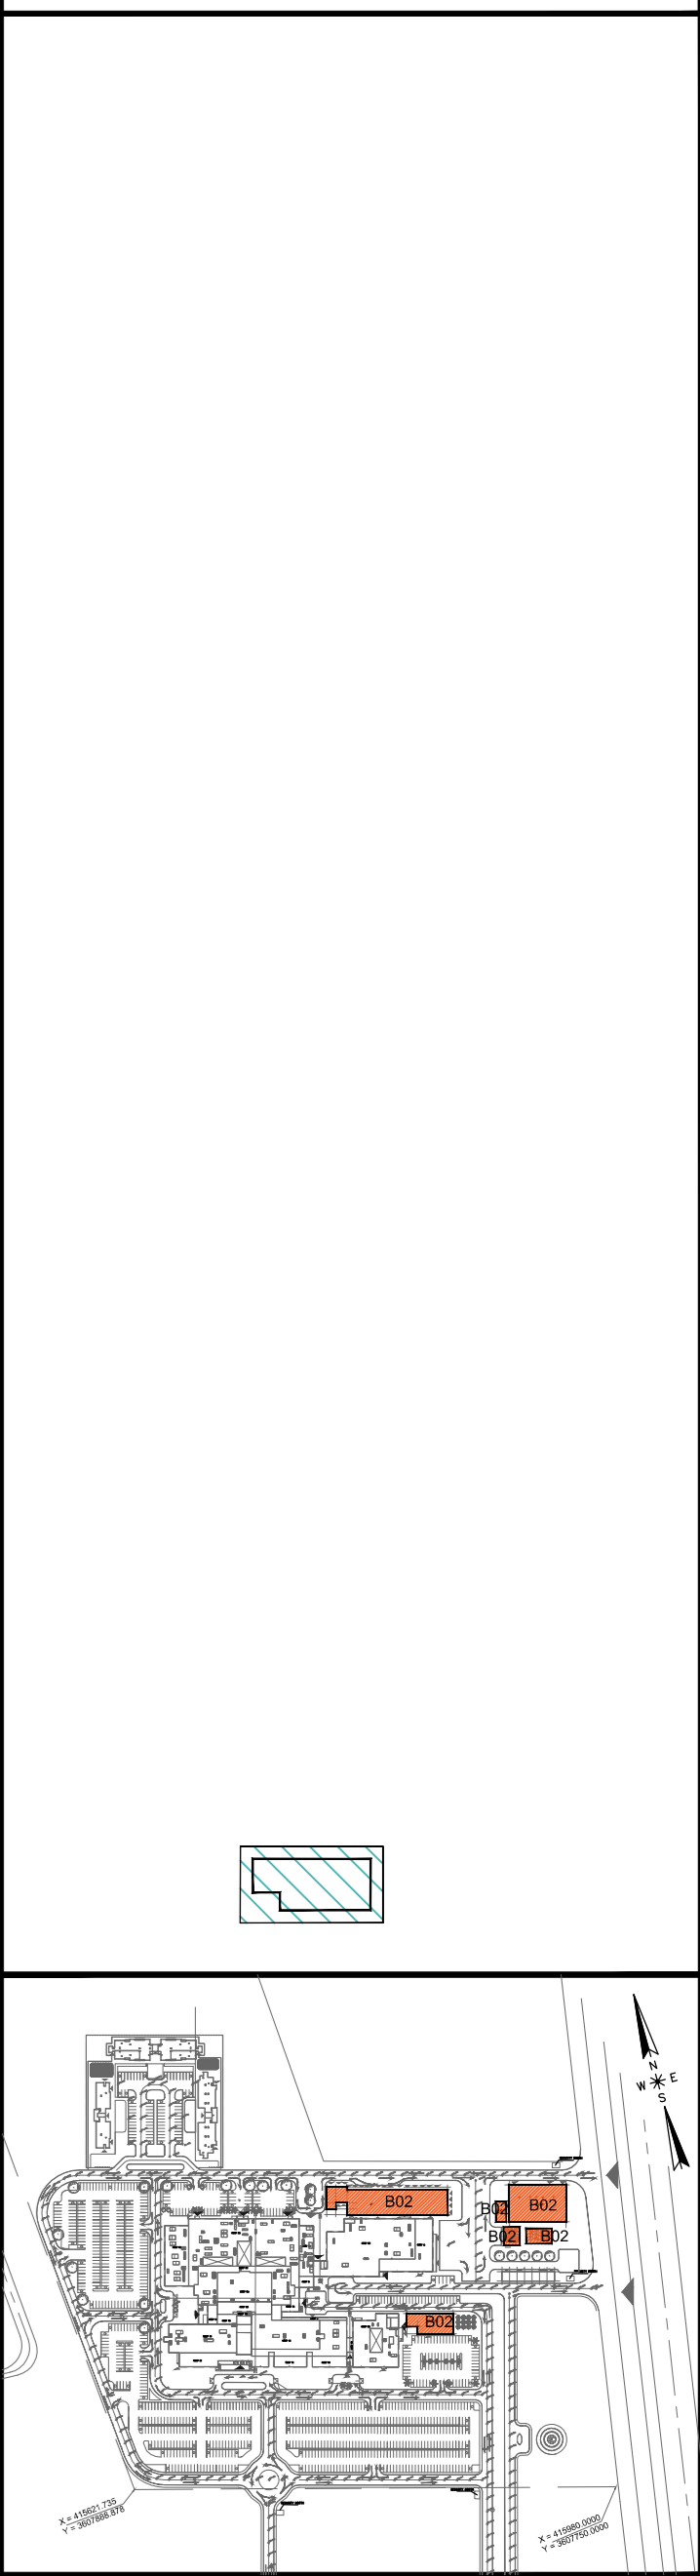

MINISTRY OF HIGHER EDUCATION AND SCIENTIFIC RESEARCH
University Of Karbala



PROJECT MANAGEMENT CONSULTANT:
AM TECH

MAIN CONTRACTOR:
FOURTH DIMENSION
Consulting Engineering & Construction
C/S.C

PRINCIPAL ENGINEERING CONSULTANT:
ARABTECH JARDANEH

CONSULTING HEALTH PLANNERS:
HDP healthcare designers
and project managers

CONSULTING INTERNATIONAL ARCHITECTS:
LEO A DALY PLANNING ARCHITECTURE ENGINEERING INTERIORS

THIS DRAWING IS THE
COPYRIGHT OF ARABTECH
JARDANEH ENGINEERS &
ARCHITECTS AND MUST NOT BE
REPRODUCED, COPIED OR USED
WITHOUT THE CONSULTANTS
AUTHORIZATION

REV.	DESCRIPTION	APPRO. BY	DATE

DRAWN BY: E.D. DESIGNED BY: A.D.
CHECKED BY: M.M.H. APPROVED BY: F.J.
QC REVIEW BY: DWG ISSUE DATE: 26.10.2014

 
PROJECT:
KARBALA 600 BED TEACHING UNIVERSITY HOSPITAL, IRAQ

CONCEPT DESIGN STAGE PRELIMINARY DESIGN STAGE
DESIGN DEVELOPMENT STAGE CONSTRUCTION DRAWINGS STAGE

DRAWING TITLE:
**BLOCK-02c ANCILLARY BUILDING
GROUND FLOOR PLAN
FIRE ALARM SYSTEM &
IT SYSTEM**

NO. 01586 DWG. KH-EW-102 BLOCK B2c
1:100 @ (A0) SHE. 01 of 01 REV. RO

General Notes :



MINISTRY OF HIGHER EDUCATION AND SCIENTIFIC RESEARCH
University Of Karbala



PROJECT MANAGEMENT CONSULTANT:
AM TECH

MAIN CONTRACTOR:
FOURTH DIMENSION
CONSULTING ENGINEERING & CONSTRUCTION

PRINCIPAL ENGINEERING CONSULTANT:
ARABTECH JARDANEH

CONSULTING HEALTH PLANNERS:
HDP healthcare designers and project managers

CONSULTING INTERNATIONAL ARCHITECTS:
LEO A DALY PLANNING ARCHITECTURE ENGINEERING INTERIORS

THIS DRAWING IS THE COPYRIGHT OF ARABTECH JARDANEH ENGINEERS & ARCHITECTS AND MUST NOT BE REPRODUCED, COPIED OR USED WITHOUT THE CONSULTANTS AUTHORIZATION

REV.	DESCRIPTION	APPD. BY	DATE


DRAWN BY: E.D DESIGNED BY: A.D
CHECKED BY: M.MH APPROVED BY: F.J
QC REVIEW BY: DWG ISSUE DATE: 26.10.2014

PROJECT:
KARBALA 600 BED TEACHING UNIVERSITY HOSPITAL, IRAQ

CONCEPT DESIGN STAGE	PRELIMINARY DESIGN STAGE
DESIGN DEVELOPMENT STAGE	CONSTRUCTION DRAWINGS STAGE

DRAWING TITLE:
BLOCK-02c ANCILLARY BUILDING GROUND FLOOR PLAN EARTHING & GROUNDING SYSTEM

AB # 01586 DWG # KH-EW-103 BLOCK # B2c
1:100 @ (A0) SHE. 01 of 01 REV # RO

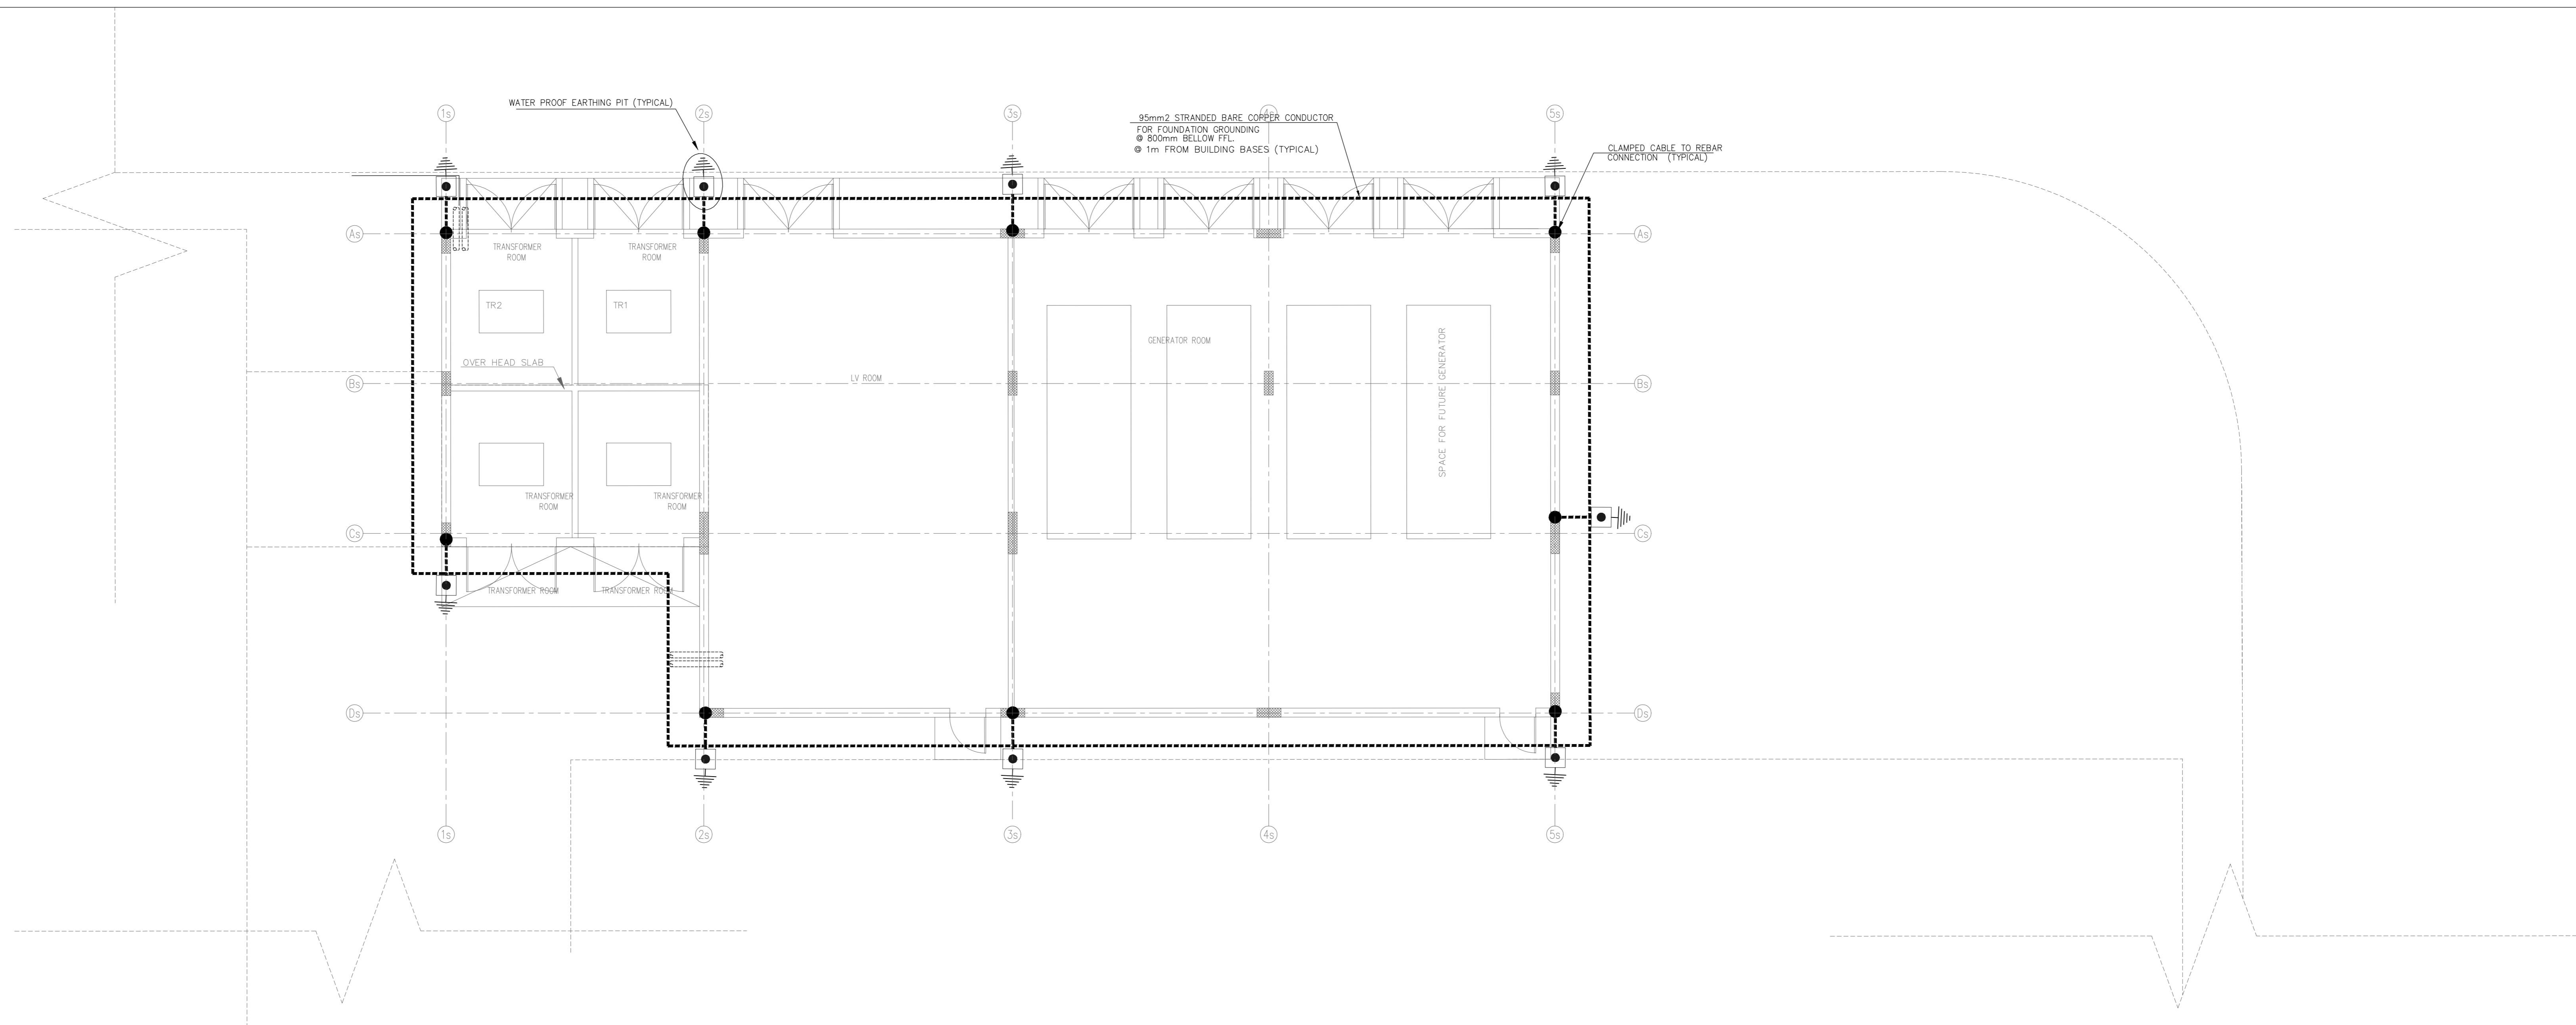

1 GROUND FLOOR EARTHING & GROUNDING SYSTEM
SCALE: 1:100